


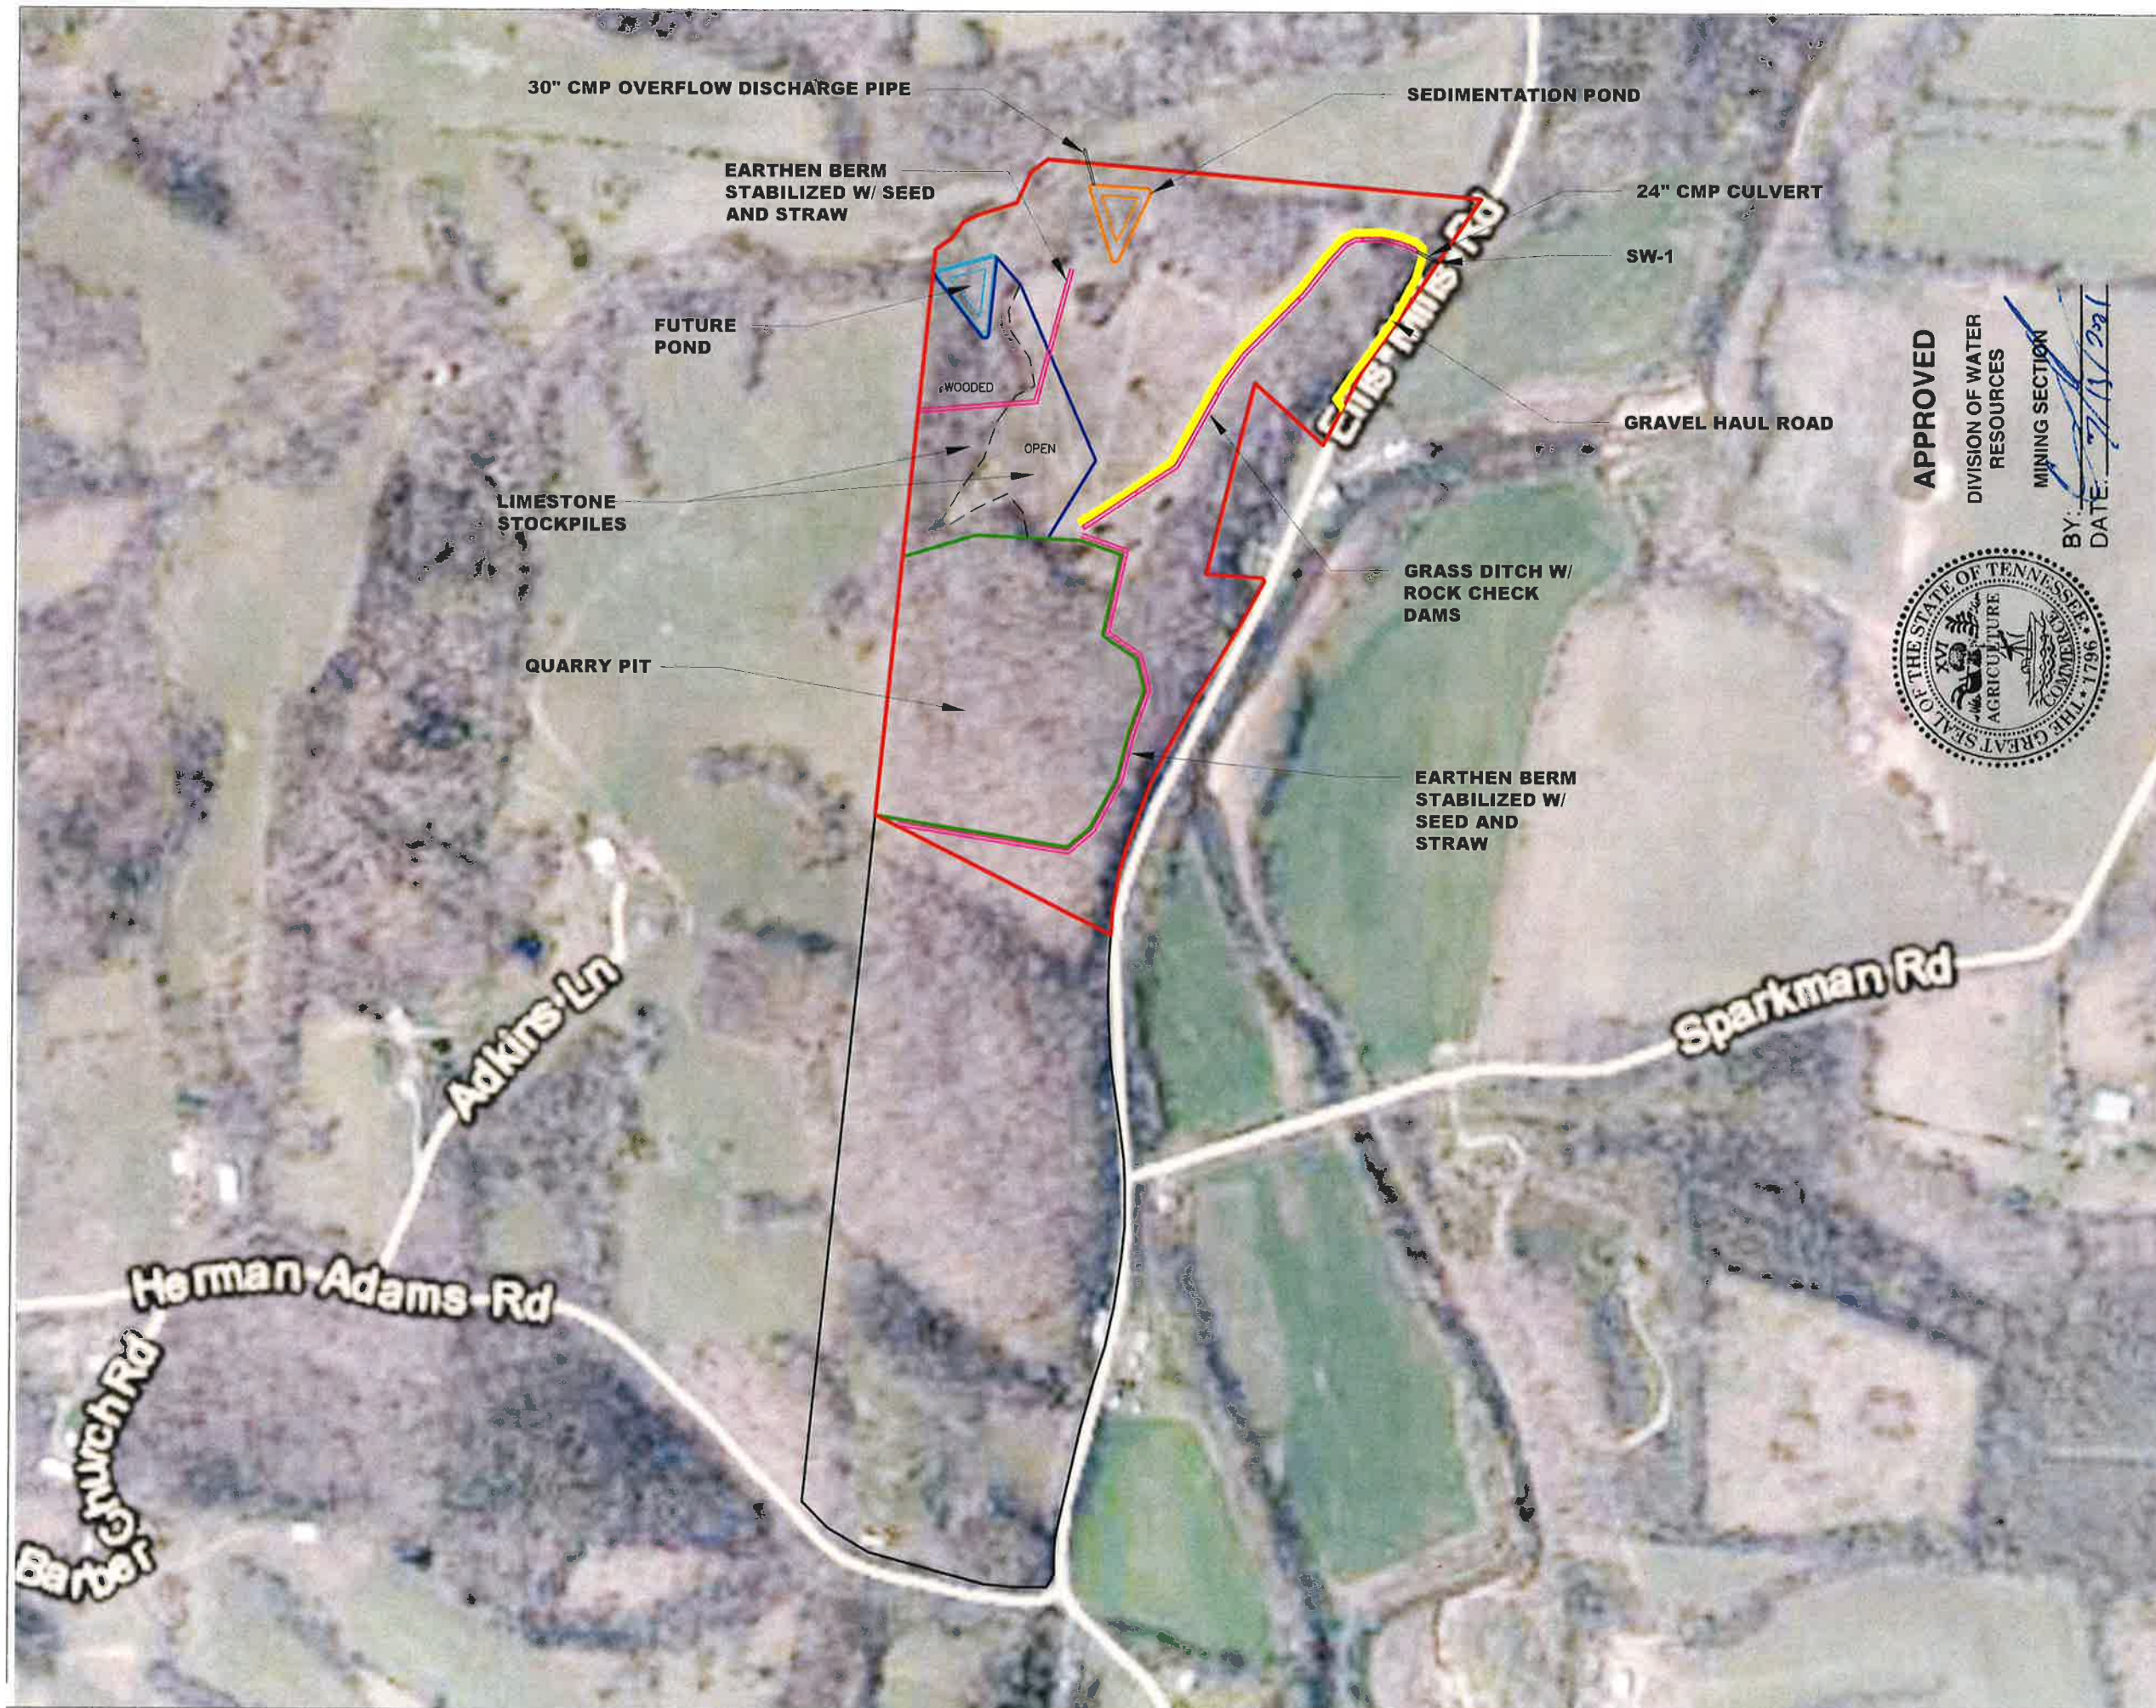

RYE
ENGINEERING PLC
& SYSTEM OPERATORS CONSULTING ENGINEERS
4210 W MAIN STREET, ERIN TN 37061
OFFICE (931) 289-2300 FAX (931) 289-2313

**YELLOW CREEK
STONE
Site Plan**

HOUSTON COUNTY, TN

APPROVED
DIVISION OF WATER
RESOURCES
MINING SECTION
BY: *[Signature]*
DATE: 11/20/2020



11/20/2020

LEGEND

- Property Boundary —
- Permit Boundary —
- BMPs —
- Quarry Pit —
- Stockpiles —
- Future Pond ▽
- Haul Road —
- Sedimentation Pond ▽

SCALE 1" = 500'

